


01
1211 UNIT18-21 - CEILING PLAN, GF 1:100

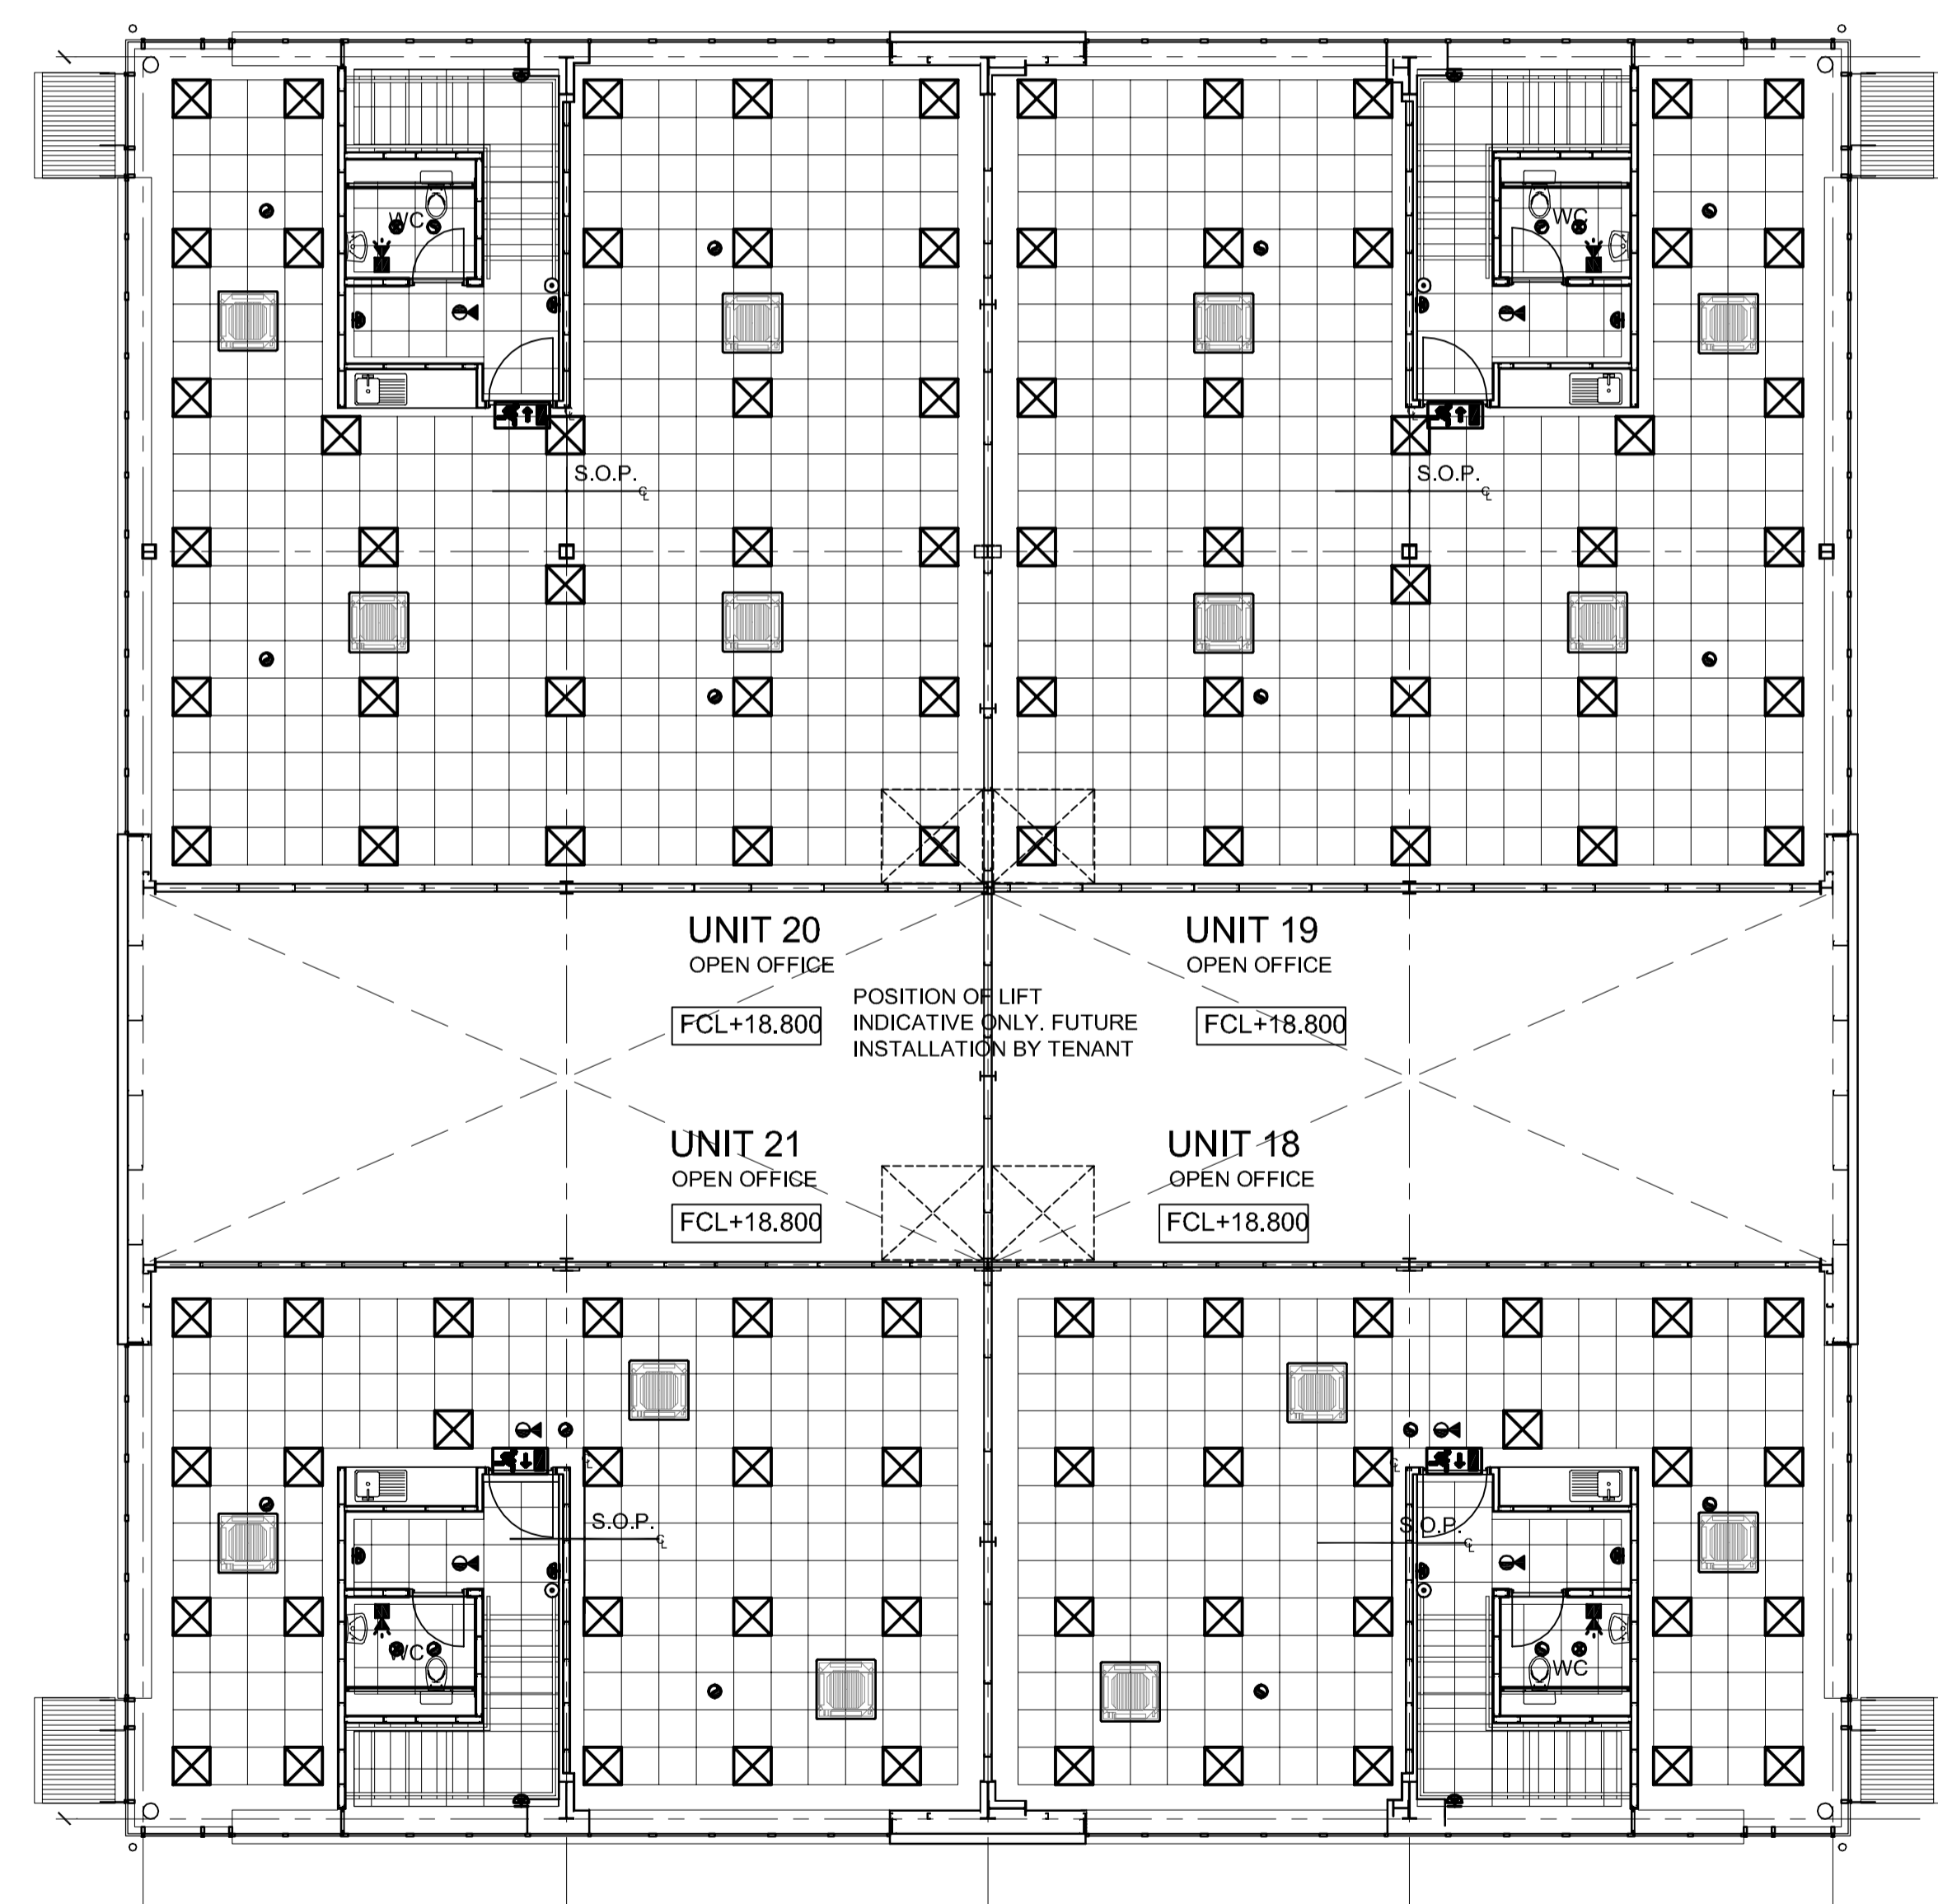

02
1211 UNIT18-21 - CEILING PLAN, FF 1:100

KEY

- AC CASSETTE
- 600mmx600mm GRILLE
- CIRCULAR GRILLE
- 600x600mm FLUORESCENT LUMINAIRE
- RECESSED DOWNLIGHTER
- PRESENCE + DAYLIGHT SENSOR
- OPTICAL SMOKE DETECTOR

ALL CEILING FITTINGS AS PER M&E SUBCONTRACTOR'S DESIGN

FOR FURTHER INFORMATION REFER TO THE RESPECTIVE M&E SUBCONTRACTOR'S DRAWING

NOTES:

SUBJECT TO STATUTORY CONSENTS

SUBJECT TO SURVEY

BASED ON OS MAP REPRODUCED BY PERMISSION OF CONTROLLER OF HM STATIONARY OFFICE (c) CROWN COPYRIGHT

COPYRIGHT RESERVED

DO NOT SCALE THIS DRAWING

DO NOT USE ELECTRONIC VERSIONS OF THIS DRAWING TO DETERMINE DIMENSIONS UNLESS SPECIFICALLY AUTHORISED BY MICHAEL SPARKS ASSOCIATES

IF USING AN ELECTRONIC VERSION OF THIS DRAWING FIGURED DIMENSIONS TAKE PRECEDENCE AND NOTIFY MICHAEL SPARKS ASSOCIATES OF ANY DISCREPANCIES

ENSURE SEALING OF ALL JUNCTIONS TO COMPLY WITH PART L

NOTE: ROOF AND WALL CLADDING TO BE DESIGNED BY SPECIALIST CONTRACTOR. CLADDING DETAILS TO BE READ IN CONJUNCTION WITH THE SPECIFICATION AND ALL RELEVANT BRITISH STANDARDS. INCLUDE VAPOUR BARRIER TAPE AROUND ALL OPENINGS AND JUNCTIONS.

ALL DIMENSIONS TO BE CHECKED ON SITE. STEEL COLUMN SIZES TO BE CONFIRMED AND TOLERANCES TO BE AGREED.

CEILING FINISH NOTES

SUSPENDED CEILINGS WILL BE PROVIDED AS FOLLOWS:-

- GENERALLY THROUGHOUT THE OFFICES AND ANCILLARY AREAS, ARMSTRONG PRIMA DUNE SUPREME 600 X 600MM REGULAR TILES IN LAY-IN GRID SYSTEM WITH A STOVE ENAMELLED FINISH ON WIRE HANGERS.
- TOILETS WILL HAVE ARMSTRONG PRIMA DUNE SUPREME 600 X 600 TILES IN LAY-IN GRID SYSTEM.
- A SHADOWLINE PERIMETER TRIMS WILL BE INCLUDED TO ALL OFFICE AREAS. THE SUSPENDED CEILING SYSTEM IS TO BE EARTH BONDED IN ACCORDANCE WITH I.E.E. REGULATIONS AND THE SUSPENDED CEILING MANUFACTURERS RECOMMENDATIONS.

NB. LAYOUT SHOWN IS INDICATIVE. SUBCONTRACTOR TO CONFIRM OPTIMUM SETTING OUT POINT TO SITE DIMENSIONS FOR ARCHITECTS APPROVAL/COMMENTS.

AS BUILT

THIS "AS-BUILT" DRAWING IS BASED ON INFORMATION SUPPLIED TO MICHAEL SPARKS ASSOCIATES BY MC LAREN CONSTRUCTION AND INCORPORATES INSTRUCTIONS AND OTHER DESIGN INFORMATION GIVEN TO MC LAREN CONSTRUCTION DIRECTLY BY OTHERS

A	30.03.2009	Refer to sub-contractors drawings for specialist details This supercedes drawing no: 2716/RE/277 rev.C	JH	NSC
REV	DATE	NOTE	DRAW	CHK

MICHAEL SPARKS ASSOCIATES
CHARTERED ARCHITECTS
11 PLATO PLACE
ST DIONIS ROAD
LONDON SW6 4TU
TELEPHONE 020 7736 6162
FAX 020 7736 3896
www.msp-architects.co.uk

FROGMORE

TITLE
CROSSWAYS, DARTFORD

DRAWING
SCHOONER PARK UNITS 18-21 REFLECTED CEILING PLANS

CLIENT
FROGMORE

DATE	SCALE	DRAWN
MARCH 2009	1:100 @ A1	JH
STATUS	CHECKED	
AS BUILT	NSC	

DRAWING NUMBER
2716 / AB / 1211 A

